


1 GROUND FLOOR PLAN
 A1/A1 SCALE 1:150 M.

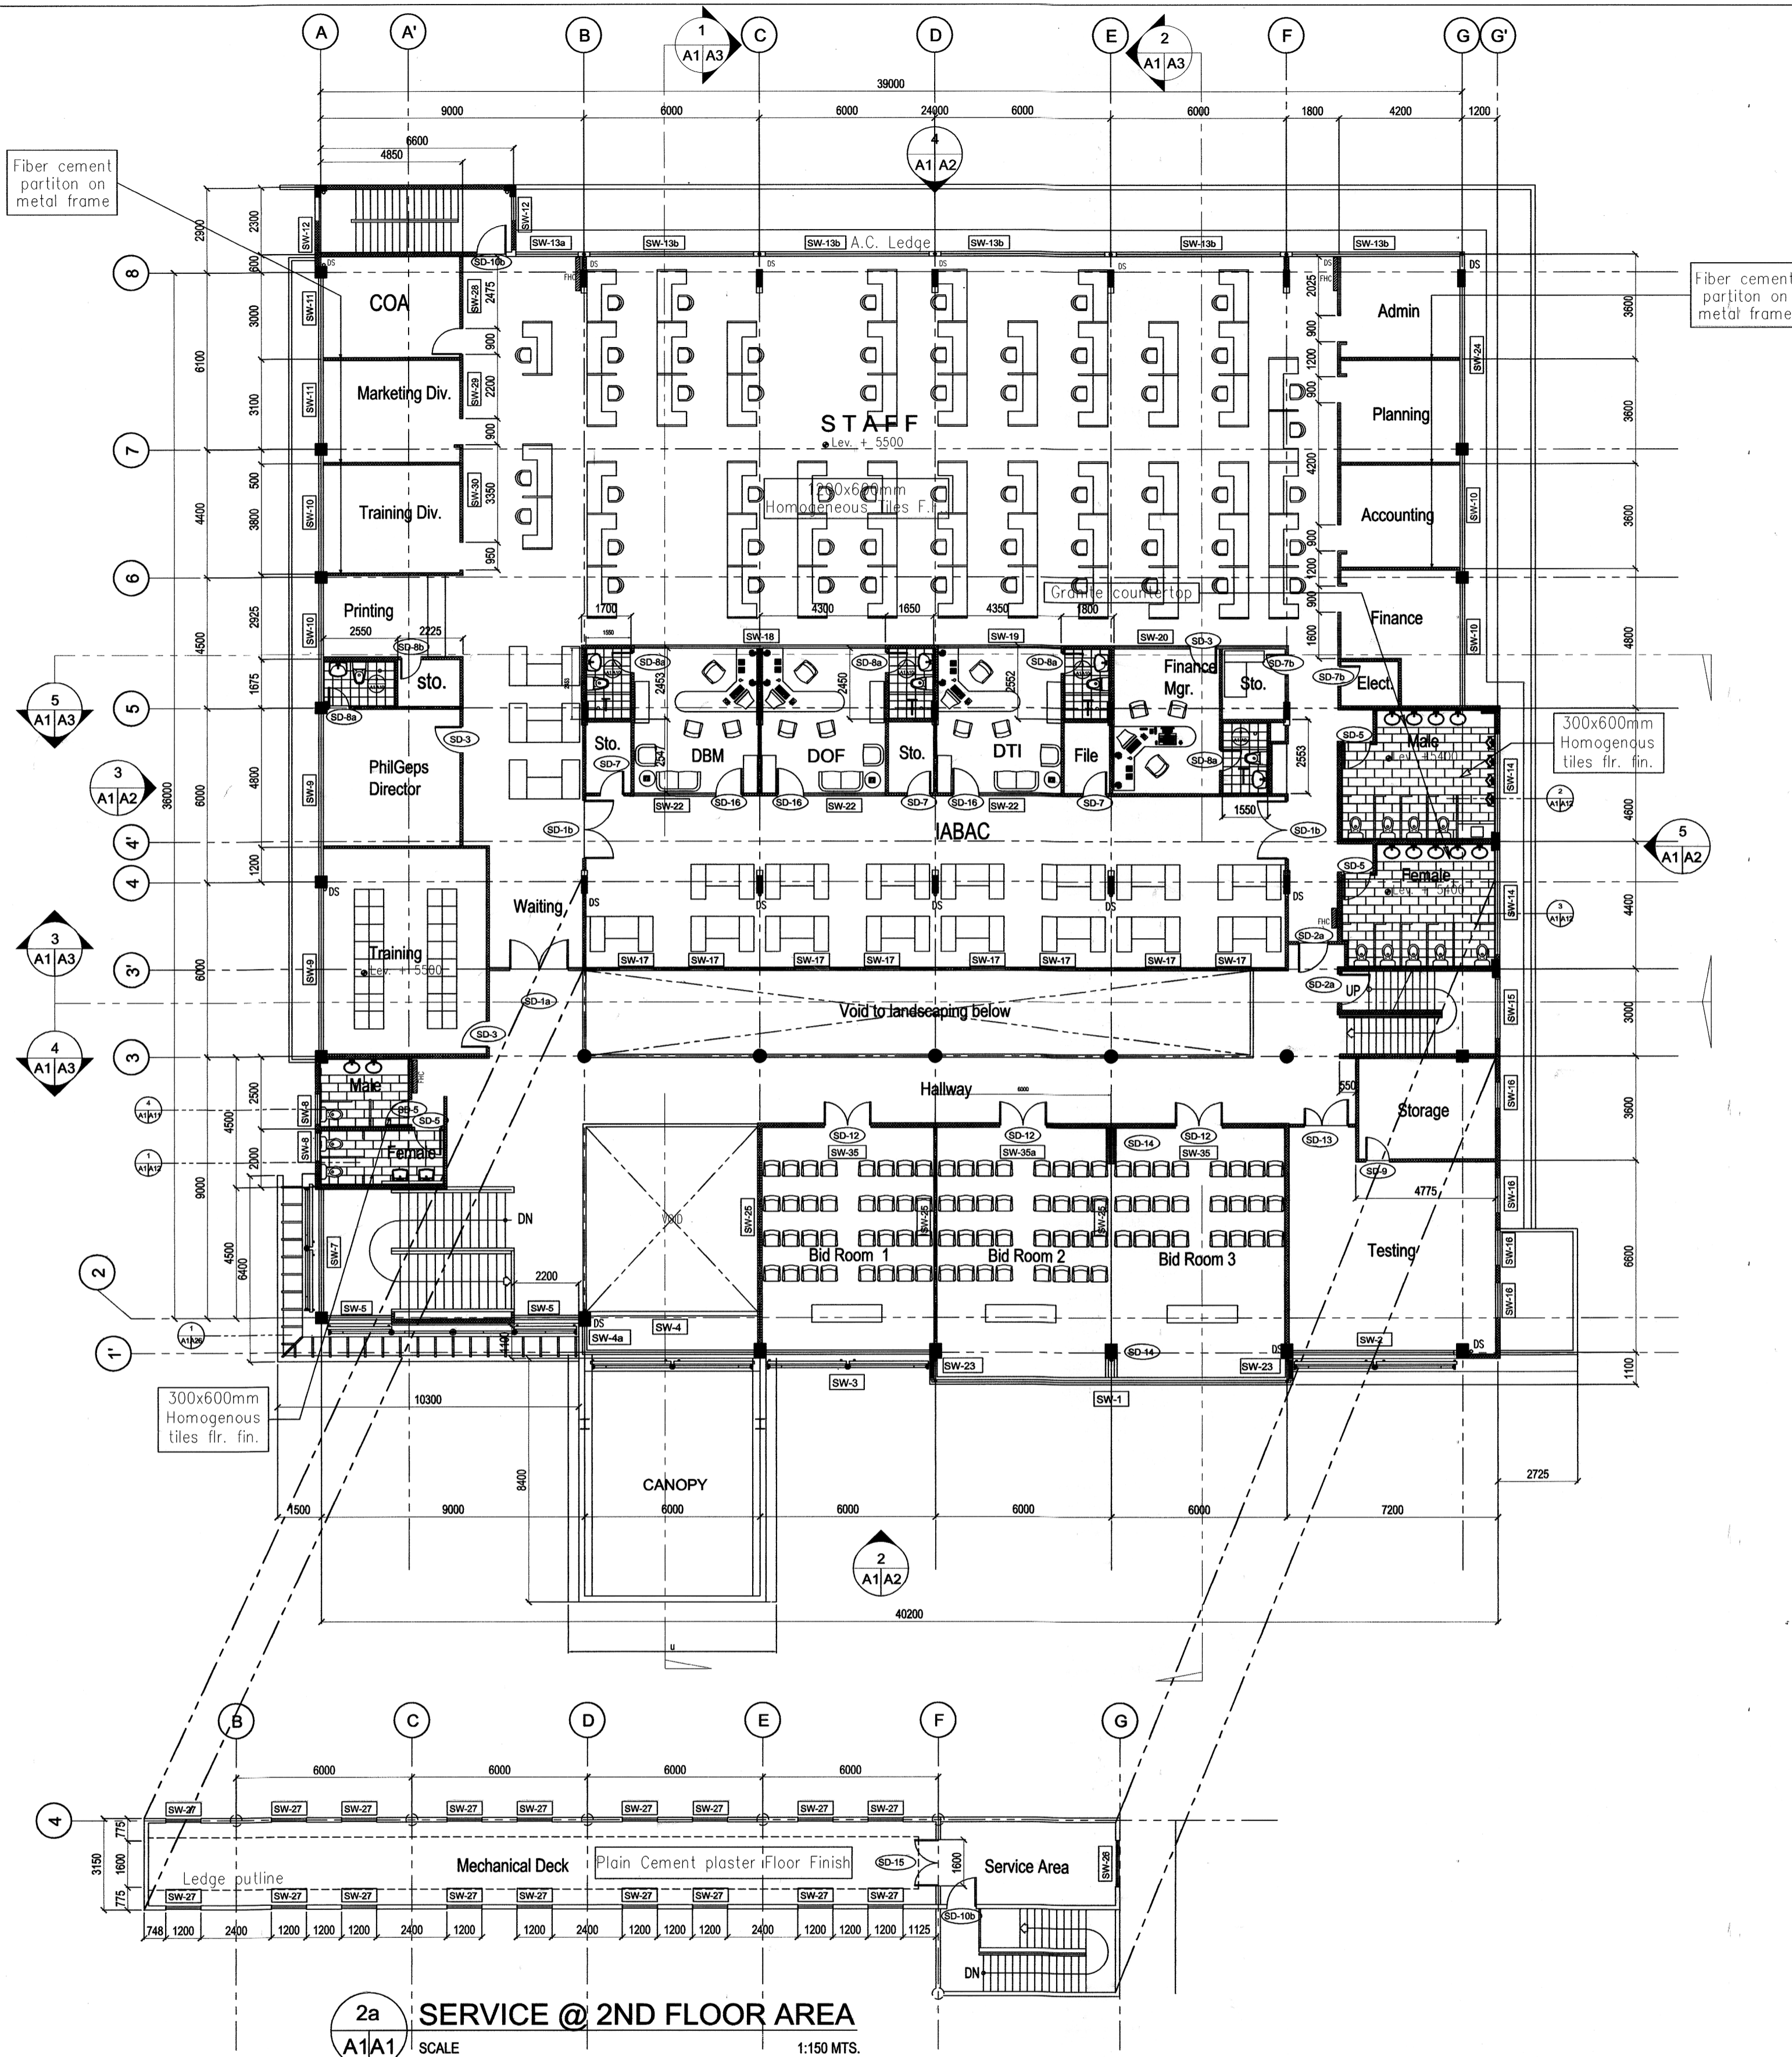

2a SERVICE @ 2ND FLOOR AREA
 A1/A1 SCALE 1:150 MTS.

PROJECT AND LOCATION : AS-BUILT PLAN DBM PROCUREMENT SERVICE BUILDING CRISTOBAL ST., PACO, MANILA	PREPARED BY : ARMANDO U. KHONG HUN GENERAL CONTRACTOR, INC. GENERAL CONTRACTOR	CHECKED BY : ENGR. MANUEL S. AVILA PROJECT ENGINEER (DBM PS)	APPROVED BY : ARCH. ALEXANDER JOSEPH CHUA CONSULTANT (DBM PS)	APPROVED BY : DIR. ESTANISLAO C. GRANADOS JR. DIRECTOR - DBM PS	SHEET NO. :
---	--	--	---	--	-----------------